
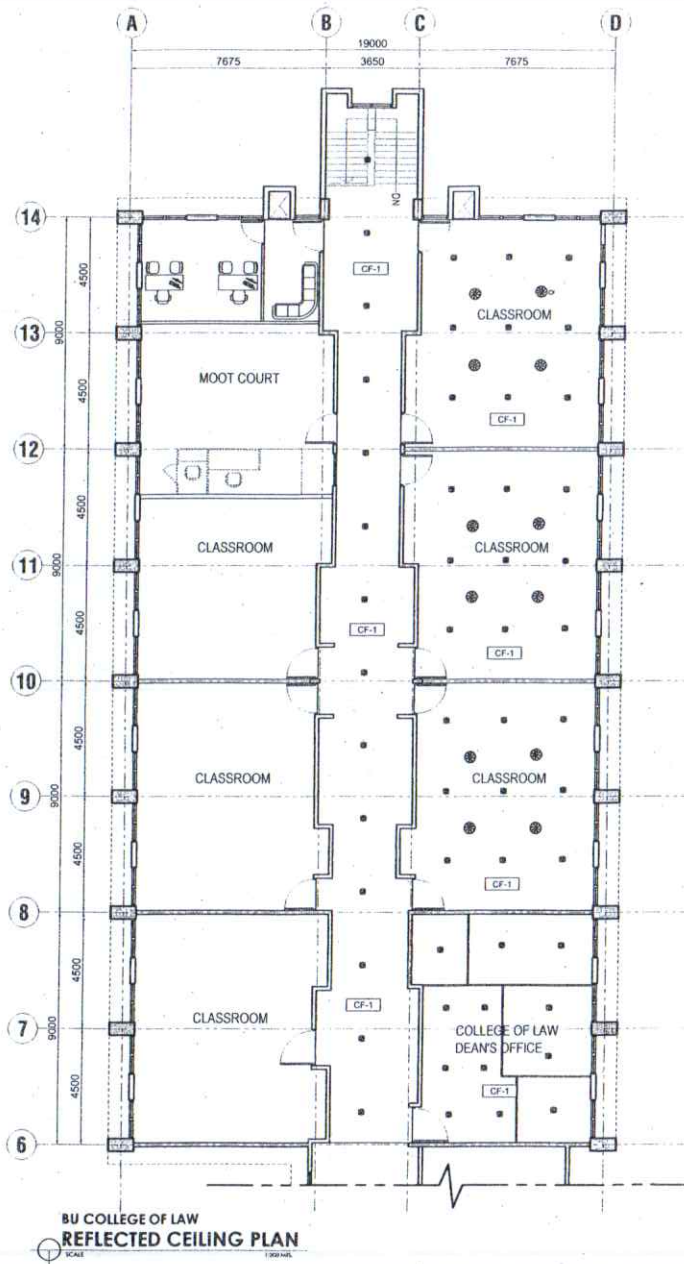



BLOW-UP FLOOR PLAN  
COLLEGE OF LAW

 <p>BICOL UNIVERSITY PHYSICAL DEVELOPMENT AND MANAGEMENT OFFICE</p>	<p>PROJECT TITLE:</p> <p><b>VARIOUS REPAIR WORKS AT BU COLLEGE OF LAW</b></p> <p>LOCATION: BU MAIN CAMPUS, LEGADY CITY</p>	<p>SHEET CONTENTS</p> <p>AS SHOWN</p>	<p>CADD: AR. JUAN HEZTY N. MORTIGA</p> <p>DESIGNED: N/A</p> <p>CHECKED: AR. ADRIAN J. GRACIA</p> <p>DATE:</p>	<p>PREPARED BY:</p> <p>AR. ADRIAN J. GRACIA</p> <p>HEAD, PLANNING &amp; DESIGN SECTION</p>	<p>PROJECT NO.</p> <p>DATE OF NO.</p> <p>PROJECT NO.</p> <p>DATE</p> <p>PLACE</p> <p>TITLE</p>	<p>VERIFIED BY:</p> <p>ENGR. OLIVER E. ALIGAN</p> <p>DIRECTOR, PDMO</p>	<p>RECOMMENDING APPROVAL:</p> <p>PROF. SONIA E. RAMOS, CPA, MBA</p> <p>VP, PLANNING &amp; DEVELOPMENT</p>	<p>APPROVED BY:</p> <p>MR. JABY BOY B. MAMIN D. NERES III</p> <p>BU PRESIDENT</p>	<p>SHEET NO.</p> <p>A 1 2</p> <p>ARCHITECTURAL</p>
			<p>MAIN CAMPUS, LEGADY CITY TEL. NO. (090) 550-1054</p>						




#### LEGEND:

CF-1  
USE 3.5mm THK. X 4'x8' FICEM BOARD 0.4mm X 5m  
DOUBLE METAL FURRING SPACED @600mm O.C.  
BOTHWAYS, 5/8"Ø X 3/4" BLIND RIVET 0.4mm X 5m  
DOUBLE METAL FURRING HANGER 0.5mm X 25mm X  
25mm X 3m WALL ANGLE (Use angle bar for wall  
angle on chb perimeter. See plan & estimates)  
WITH 0.60M X 0.60M MANHOLE

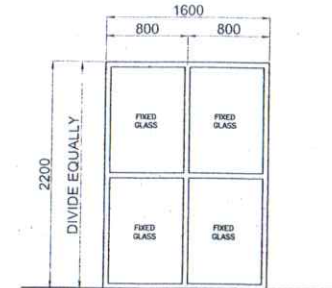

TYPE	ALUMINUM FRAMED POWDER COATED FIXED GLASS PANEL WITH 1/2" THK. CLEAR GLASS
QTY:	1 SET
LOC.	EMERGENCY EXIT (STAIRWELL)

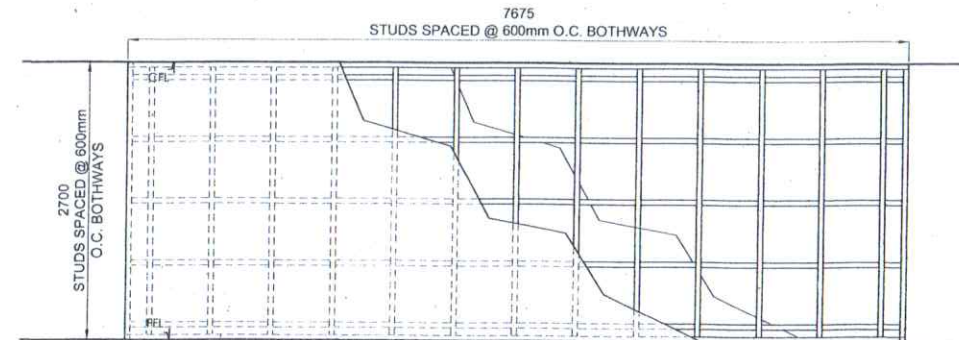

**DRYWALL PARTITION DETAIL**  
SCALE 1:50 NBS



BICOL UNIVERSITY  
PHYSICAL DEVELOPMENT  
AND MANAGEMENT OFFICE

MAIN CAMPUS, LEGAZPI CITY  
TEL. NO. (092) 400-0394

PROJECT TITLE

**VARIOUS REPAIR WORKS AT BU  
COLLEGE OF LAW**

LOCATION: BU MAIN CAMPUS, LEGAZPI CITY

SHEET CONTENTS

AS SHOWN

CADD: AN. JAVIN NEZTY N. MONTENA

DESIGNED BY:

CHECKED: AN. AGRAN & GRACER

DATE:

PREPARED BY:

AN. AGRAN, GRACER

HEAD, PLANNING & DESIGN SECTION

PRC NO.

WAPR NO.

PER NO.

DATE:

PLACE:

TH:

VERIFIED BY:

ENGR. OLIVER E. ALICAN

DIRECTOR, POMO

RECOMMENDING APPROVAL:

PROF. SONNIE A. RAMOS, CPA, MBA

VP, PLANNING & DEVELOPMENT

APPROVED BY:

DR. BABY BOY BENJAMIN D. NABRES III



BU PRESIDENT




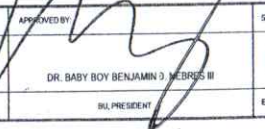
SHEET NO.

A 2

ARCHITECTURAL

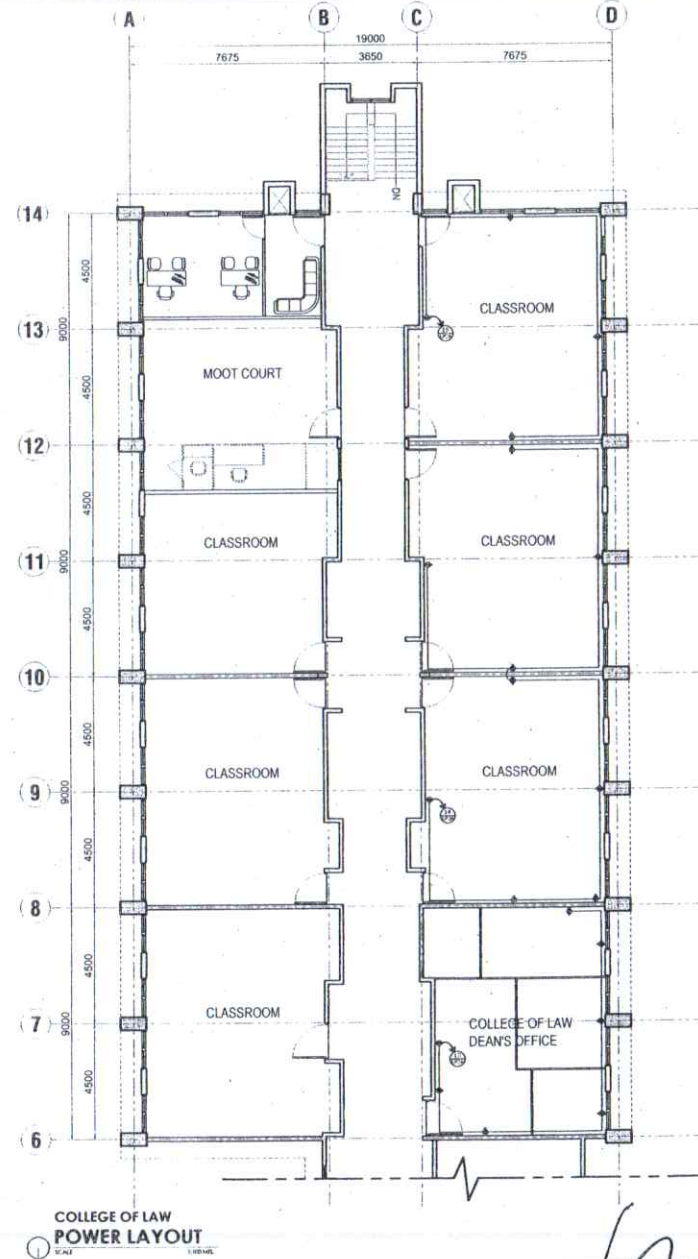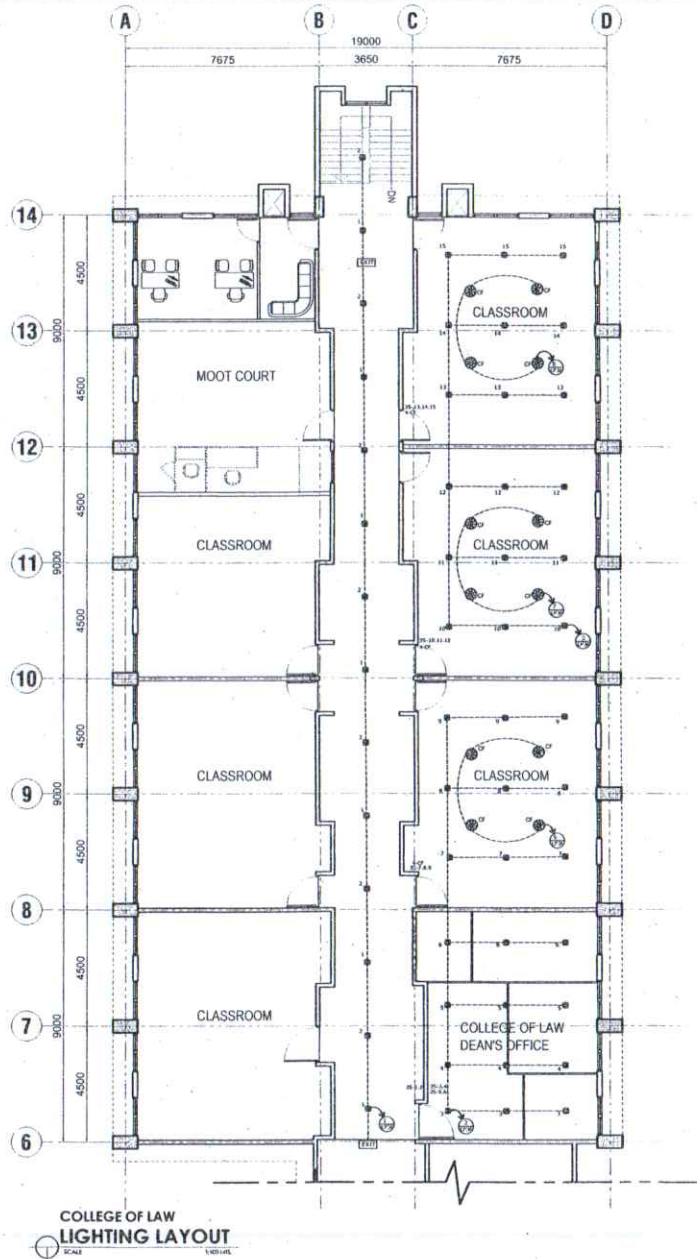



 BICOL UNIVERSITY PHYSICAL DEVELOPMENT AND MANAGEMENT OFFICE MAIN CAMPUS, LEGAZPI CITY TEL. NO. 7052-456-456	PROJECT TITLE: <b>VARIOUS REPAIR WORKS AT BU COLLEGE OF LAW</b>	SHEET CONTENTS: AS SHOWN	DESIGNED BY: CHECKED BY: AR. ADRIAN J. ORGEDA DATE:	PREPARED BY: AR. ADRIAN J. ORGEDA HEAD, PLANNING & DESIGN SECTION	PRC NO.: DATA NO.: PDR NO.: DATE: PLACE: TIN:	VERIFIED BY:  ENGR. DUVERTE ALUJAN DIRECTOR, PDMO	RECOMMENDING APPROVAL:  PROF. SONNIE A. RAMOS, CPA, MBA VP, PLANNING & DEVELOPMENT	APPROVED BY:  DR. BABY BOY BENJAMIN D. MOBERG III BU PRESIDENT	SHEET NO.: <b>E 1 2</b> ELECTRICAL
	LOCATION: BU MAIN CAMPUS, LEGAZPI CITY								